

SCCFA

August 30 - September 1, 2020

Hyatt Regency Atlanta - Centennial Ballroom

Atlanta, GA



Show Information	
Show Name	SCCFA
Show Dates	August 30 - September 1, 2020
Move-In	2020
Job #	G437350720
AE	Paula Herz

Inventory as of 07/15/2020			
Dimension	Size	Qty	SqFt
8'x10'	80	46	3,680
Totals:		46	3,680


Floor Plan Legend	
FE	Fire Extinguisher
FS	Fire Strobe
FHC	Fire Hose Cabinet

Venue Info	
Building Name	Hyatt Regency Atlanta
Hall	Centennial Ballroom
Floor	----
Address	265 Peachtree St Atlanta, GA 30303

Drawing Information	
File Path	J:\01_Floor Plans_01_SES SHOW_FLOORPLANS\202007_AJA\Hyatt Regency Monthly_G437350720
File Name	Hyatt Regency Monthly_G437350720.dwg
Drawn By	Lierin Gorsky
Last Saved	7/21/2020 1:16 PM
Saved By	Tmckee
Tab	Floorplan
Paper Size	ANSI full bleed A (11.00 x 8.50 Inches)
Scale	NTS

1531 Carroll Drive NW
Atlanta, GA 30318
(v) 404-720-8600
(f) 404-720-8750

7/21/2020 1:17 PM THERSON, CARINATELLA

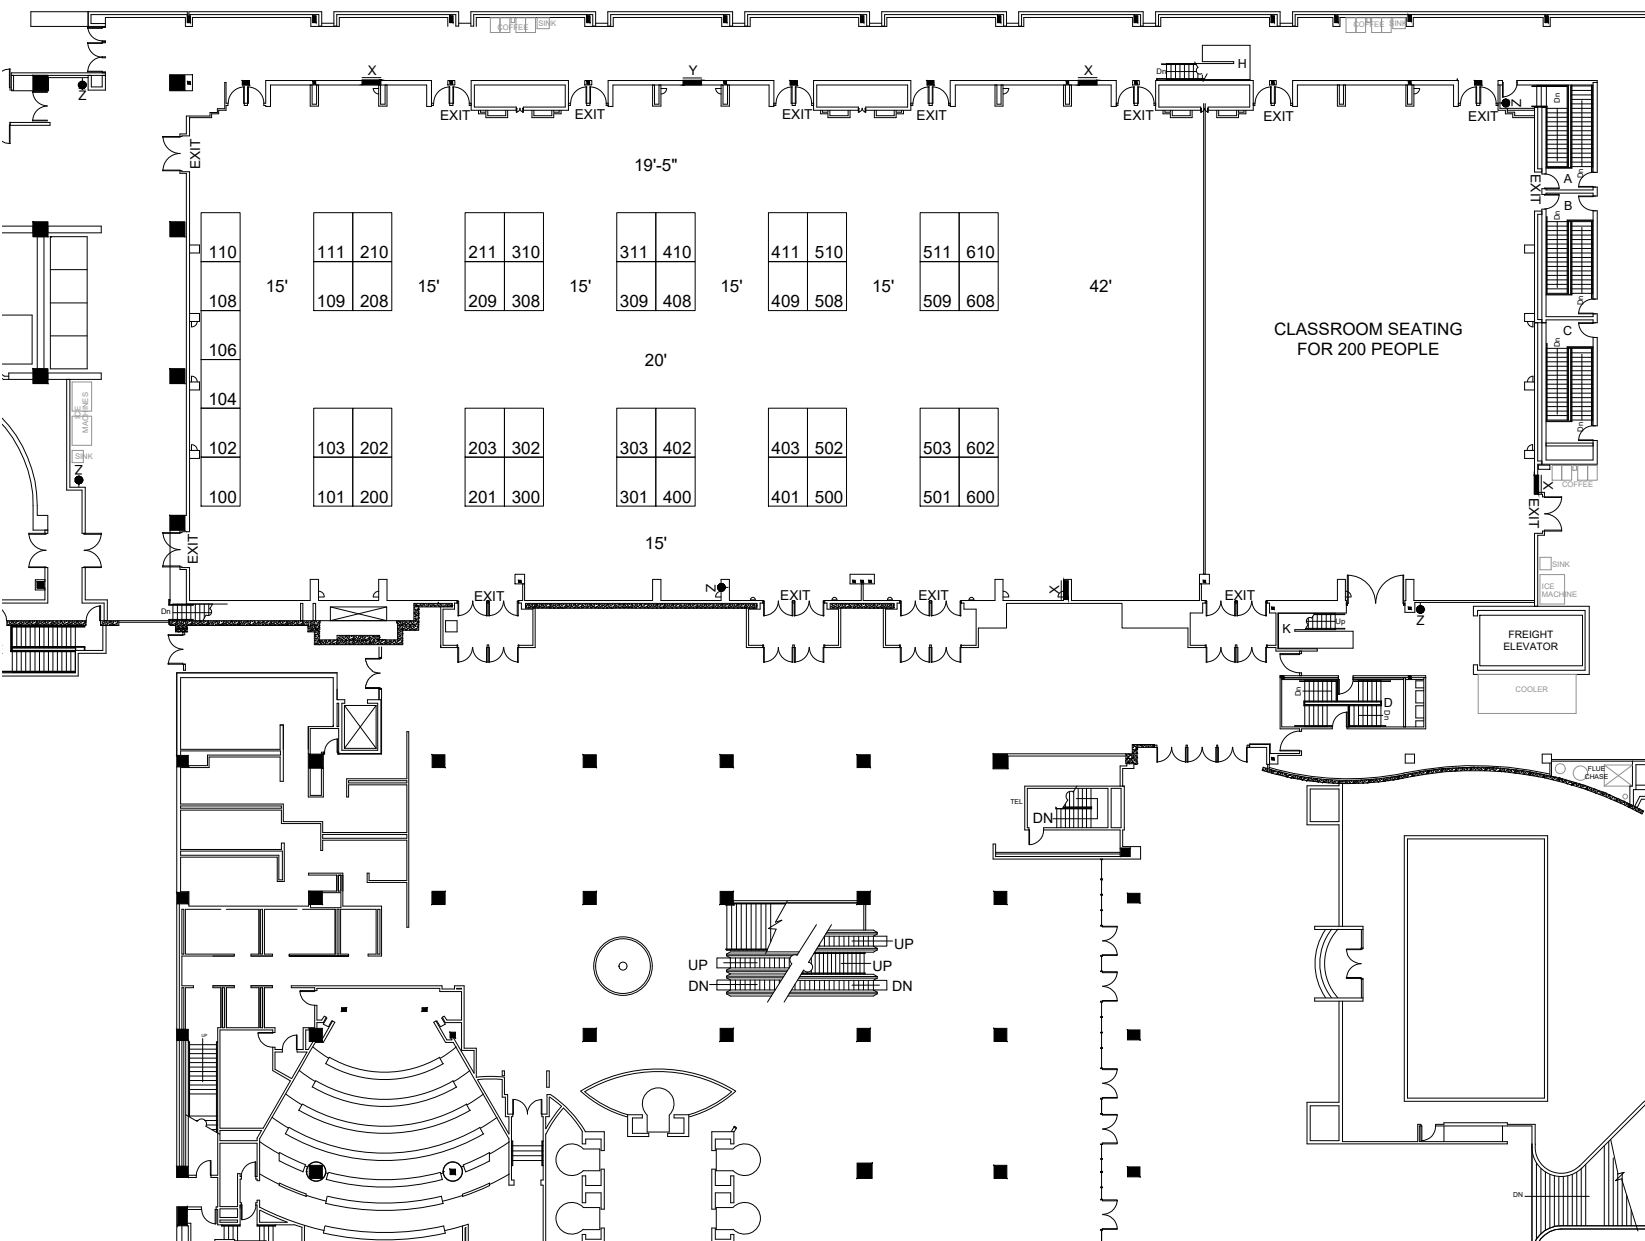

Shepard Exposition Services has made every effort to ensure the accuracy of all information contained on this floor plan. However, no warranties, either expressed or implied, are made with respect to this floor plan. Verifying the locations of building columns, utilities, or other architectural components of the facility is the sole responsibility of the exhibitor/show management.

SUBJECT TO FIRE MARSHAL APPROVAL